



Forsyth County Procurement

Greg Bridges, NIGP-CPP, Procurement Agent III

July 14, 2022

ADDENDUM #1

RFQ No. 22-076-3320

For: Geotech Services for Church Rd. and Martin Rd. Gravity Sewer

This addendum supersedes and supplements all portions of the bidding documents and becomes part of the contract documents for the above-referenced project.


Where any item called for in the specifications or indicated on the drawings is supplemented hereby, the original requirements shall remain in effect.

Where any original item is amended, voided or superseded hereby, the provision of such item not so specifically amended, voided or superseded shall remain in effect.


Attachment 1 Boring Locations:

ATTACHMENT A
Boring Locations


Boring Number	Location	Approx. Existing Grade Elevation	Remarks	Boring Depth
B-1	MH01 STA 10+00	1174	Doghouse Manhole #1	20 ft
B-2	MH03 STA 13+92	1180	Manhole #3	15 ft
B-3	MH04 STA 16+21	1197	Manhole #4	25 ft
B-4	MH05 STA 18+93	1192	Manhole #5	10 ft
B-5	MH06 STA 21+81	1210	Manhole #6	25 ft
B-6	MH08 STA 26+20	1196	Manhole #8	10 ft
B-7	MH10 STA 30+30	1209	Manhole #10	15 ft
B-8	MH012 STA 34+52	1226	Manhole #12	10 ft

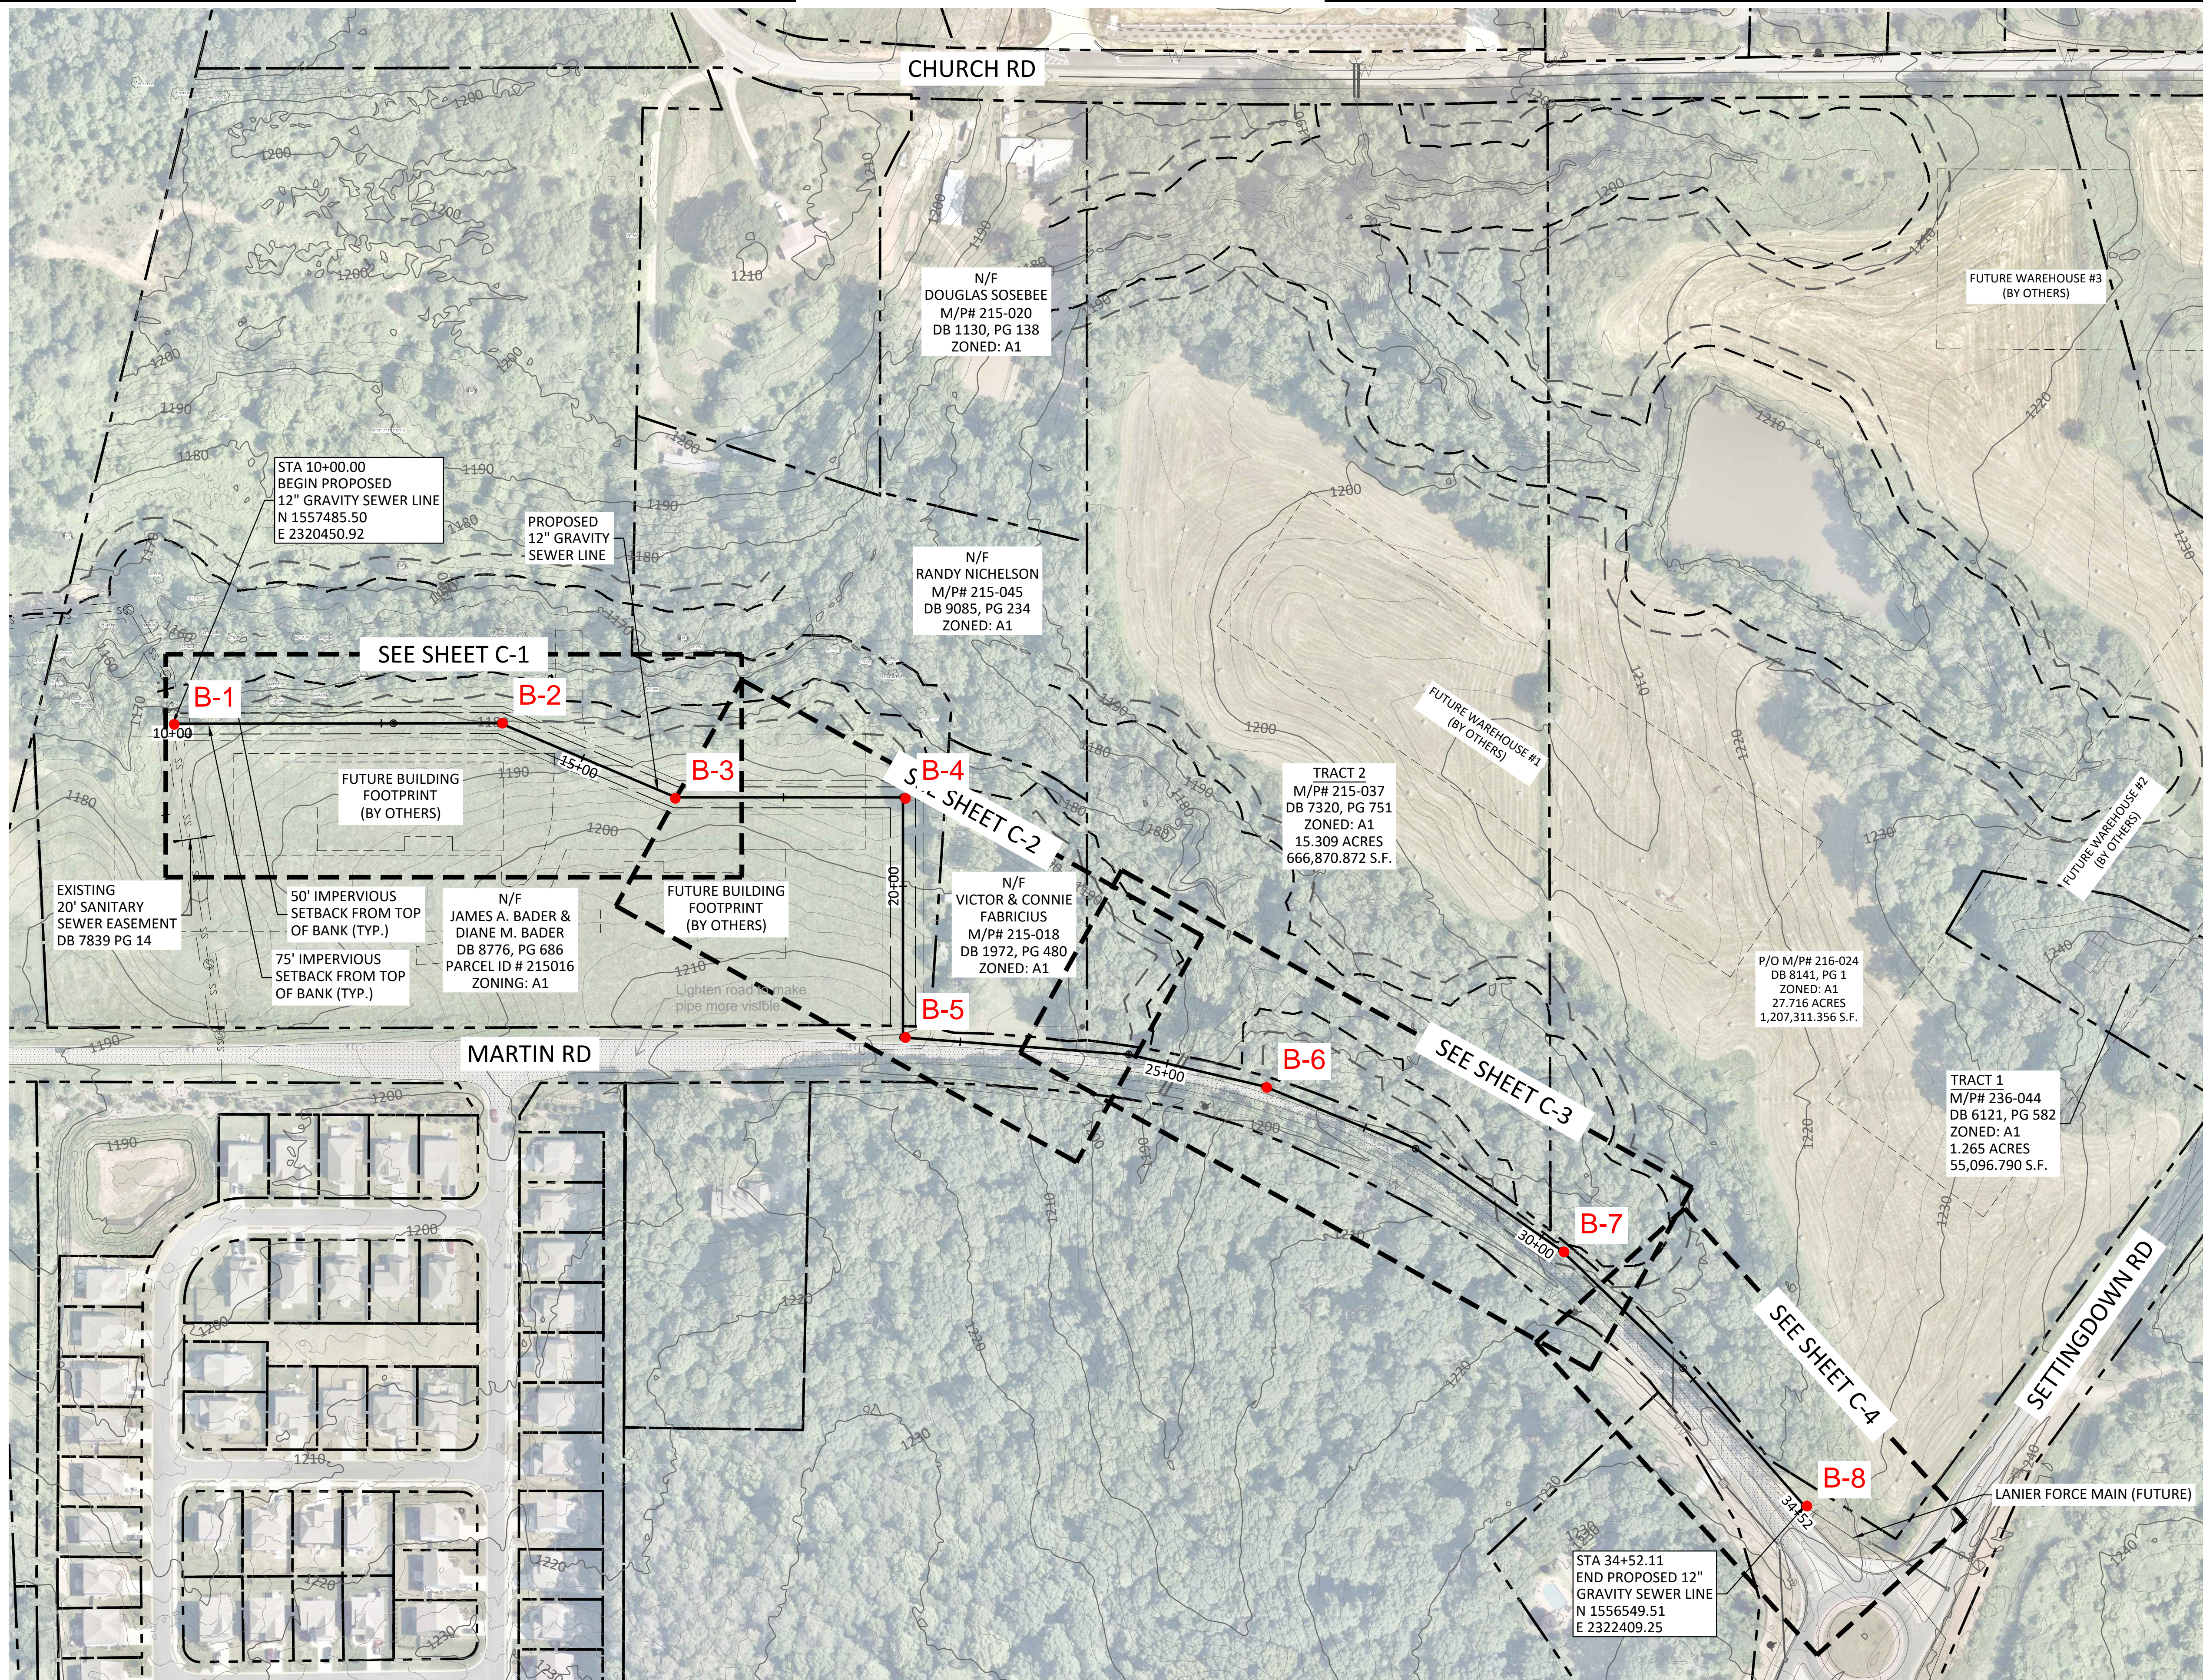

ACAD Ref: 24.1s (IMS Tech)
 Filename: N:\WTU\Drawings\CV-PL-SITE01.dwg
 Last Saved: 6/9/2022 9:48 AM Saved By: 04327

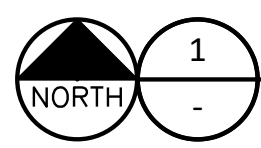

1
 PROPOSED SITE PLAN
 1" = 100'

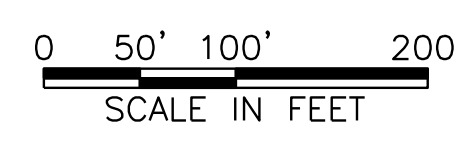

60% SUBMITTAL

NOT FOR CONSTRUCTION
 THIS DOCUMENT IS RELEASED FOR THE
 USE OF THE CLIENT ONLY. IT IS THE
 AUTHORITY OF WILLIAM ROYCE HACKETT
 GEORGIA NO. PE000572 ON DATE: JUNE 2022
 IT IS NOT TO BE USED FOR CONSTRUCTION,
 BIDDING OR PERMIT PURPOSES.

FREESSE NICHOLS
 360 Interstate North Parkway,
 Atlanta, GA 30330
 Phone: (404) 334-4310
 Web: www.freesse.com


FORSYTH COUNTY DEPARTMENT OF WATER AND SEWER
CHURCH AND MARTIN GRAVITY SEWER
 GENERAL
 KEY PLAN

NO.	ISSUE	BY	DATE	FRN JOB NO.
3	90% DRAFT - FOR REVIEW	WRH	X/XX/XXXX	FSY21947
2	60% DRAFT - FOR REVIEW	WRH	5/16/2022	DATE: JUNE 2022
1	30% DRAFT - FOR REVIEW	WRH	2/25/2022	DESIGNED AFS DRAWN SUJ REVISOR JAR
0	VERIFY SCALE			CHECKED WPRH FILE NAME CV-PL-SITE01.dwg


Bar is one inch on original drawing. If not one inch on this sheet, adjust scale.

SHEET **G-3**

SEQ.

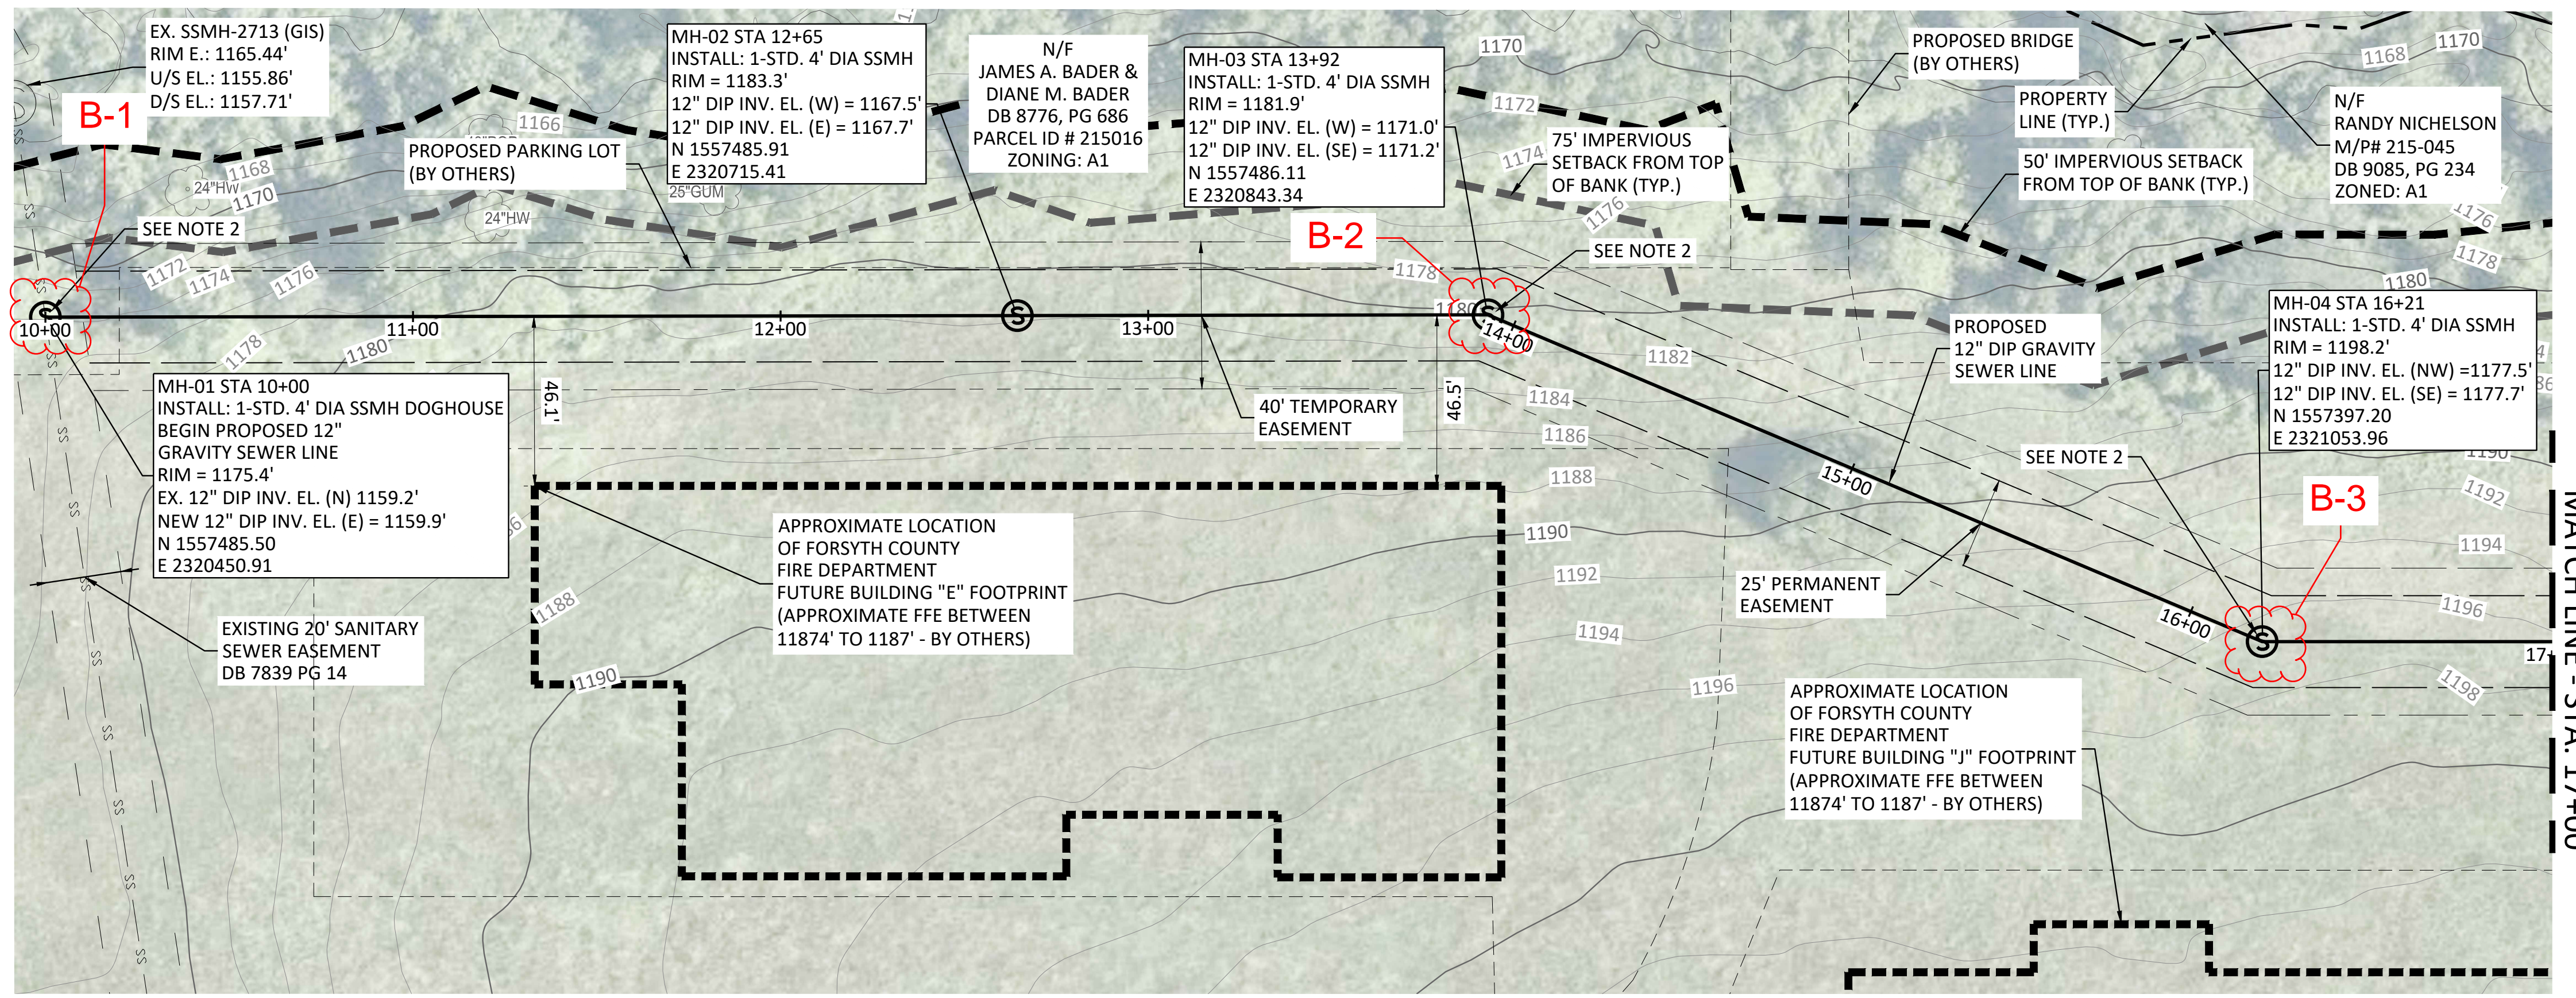

PLAN

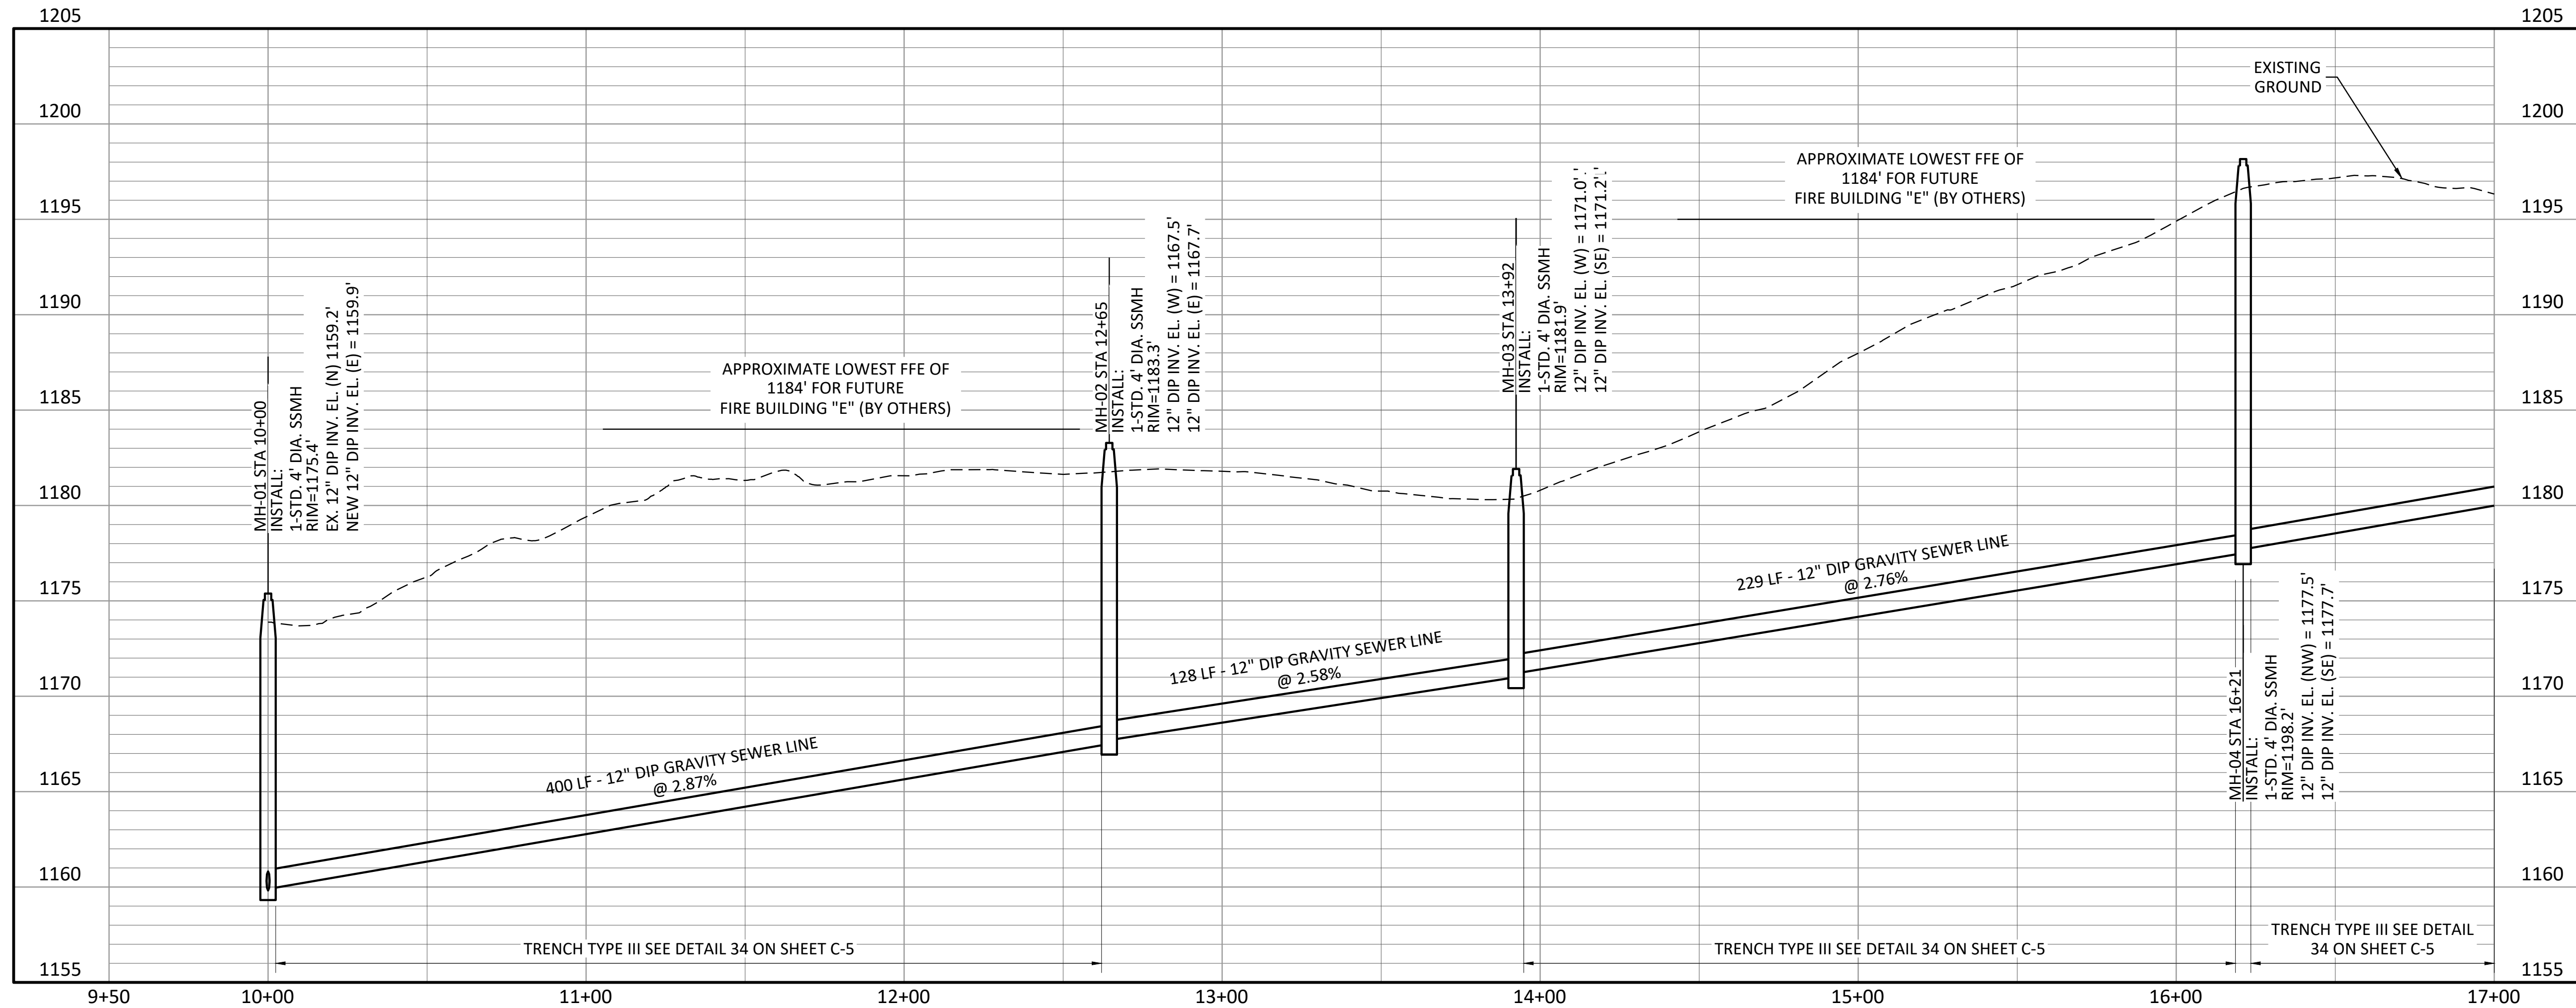

PROFILE

- NOTES:
- CONTRACTOR TO CONFIRM FINAL MANHOLE RIM ELEVATION WITH CITY.
 - ALL MANHOLES LOCATED IN THE FUTURE PAVING PARKING LOT AREA SHALL BE TRAFFIC RATED FRAME AND COVER AS SHOWN IN DETAIL 46.


NOT FOR CONSTRUCTION
 THIS DOCUMENT IS RELEASED FOR THE PROJECT ONLY. IT IS NOT TO BE USED FOR BIDDING OR PERMIT PURPOSES.
 AUTHORITY OF: WILLIAM ROYCE HACKETT
 GEORGIA NO. PE000572 ON DATE: JUNE 2022

FREESSE NICHOLS
 360 Interstate North Parkway
 Atlanta, GA 30330
 Phone - (404) 334-4310
 Web - www.freesse.com

FORSYTH COUNTY DEPARTMENT OF WATER AND SEWER
CHURCH AND MARTIN GRAVITY SEWER
 CIVIL
 PLAN AND PROFILE - STA. 10+00 TO STA. 17+00


NO.	ISSUE	DATE	BY	FILE NAME
3	90% DRAFT - FOR REVIEW	7/15/2022	WRH	CV-PP-PIPE01.dwg
2	60% DRAFT - FOR REVIEW	5/16/2022	WRH	
1	30% DRAFT - FOR REVIEW	2/25/2022	WRH	
0	VERIFY SCALE			

Bar is one inch on original drawing. If not one inch on this sheet, adjust scale.

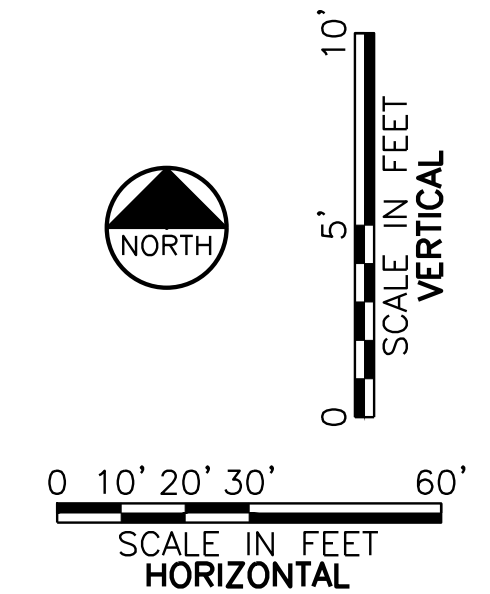

90% SUBMITTAL


ACAD Ref: 24.1s (IMS Tech)
 Filename: N:\W\T\Drawings\CV-PP-PIPE01.dwg
 Last Saved: 6/15/2022 9:25 AM. Saved By: 04327

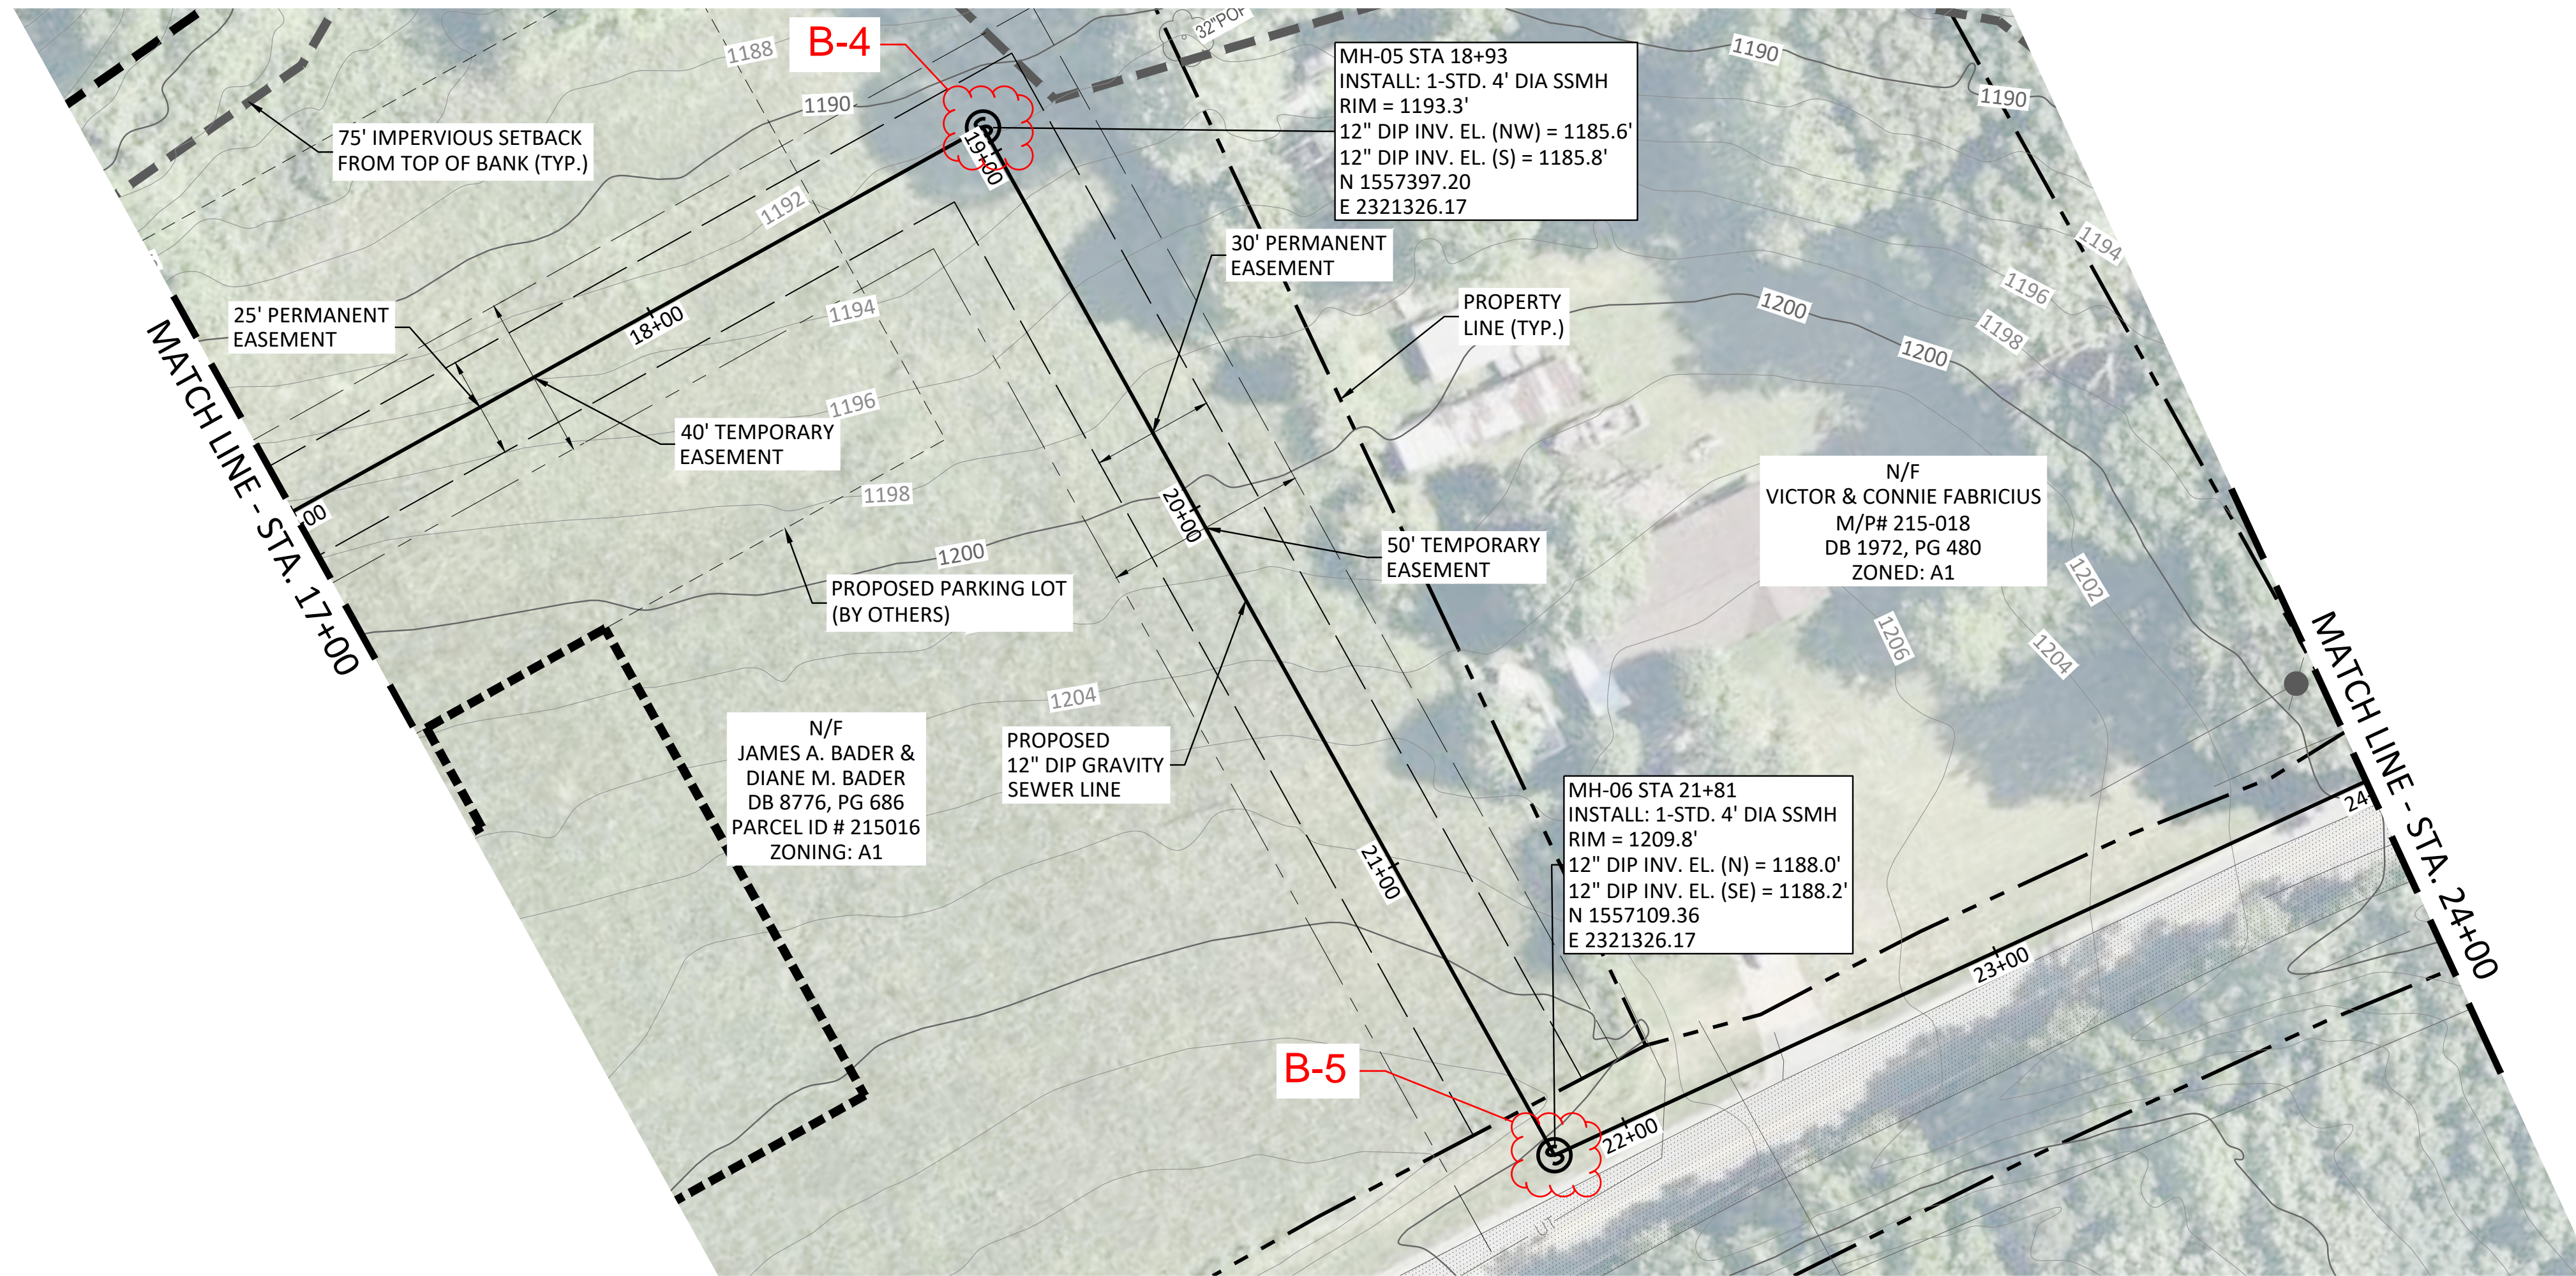


PLAN

NOTES:

1. USE TRENCH SAFETY PROTECTION TO MINIMIZE TRENCH WIDTH ALONG RIGHT OF WAY.
2. ALL MANHOLES LOCATED IN THE FUTURE PAVING PARKING LOT AREA SHALL BE TRAFFIC RATED FRAME AND COVER AS SHOWN IN DETAIL 46.
3. SINGLE LANE CLOSURE ALONG MARTIN ROAD. PAVEMENT REPAIRS TO CENTERLINE.

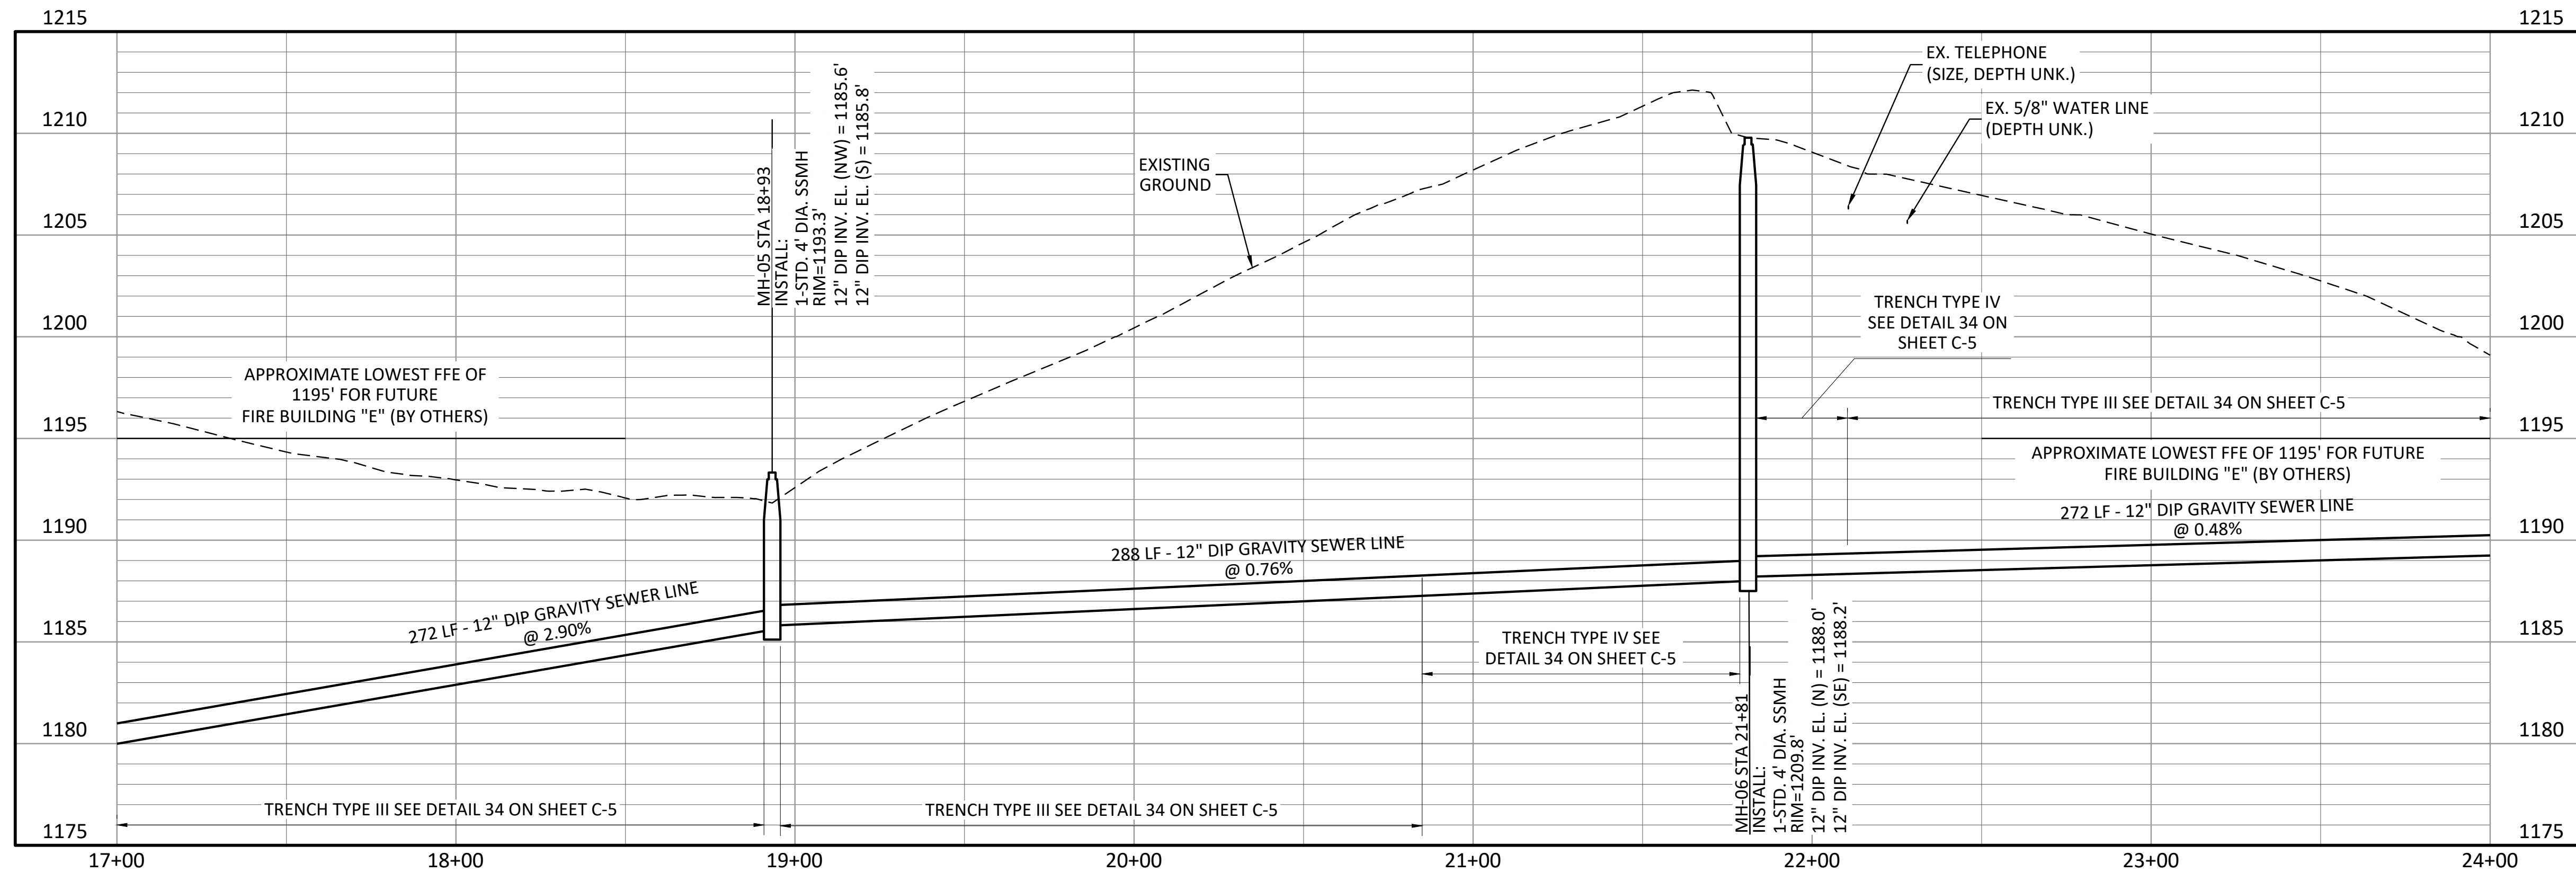

PROFILE

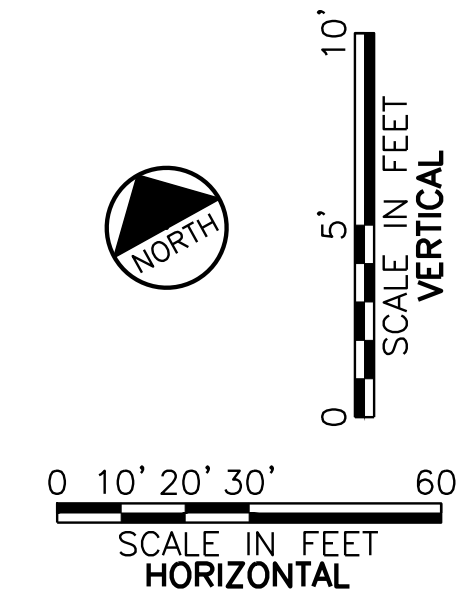

90% SUBMITTAL

NOT FOR CONSTRUCTION
 THIS DOCUMENT IS RELEASED FOR THE USE OF THE CLIENT AND IS NOT TO BE USED FOR BIDDING OR PERMIT PURPOSES.
 AUTHORITY OF: WILLIAM ROYCE HACKETT
 GEORGIA NO. PE000572 ON DATE: JUNE 2022
 IT IS NOT TO BE USED FOR CONSTRUCTION, BIDDING OR PERMIT PURPOSES.

FREESSE NICHOLS
 Georgia Registered Engineering Firm PE# 004433
 360 Interstate North Parkway,
 Atlanta, GA 30339
 Phone - (404) 334-4310
 Web - www.freesse.com

FORSYTH COUNTY DEPARTMENT OF WATER AND SEWER
CHURCH AND MARTIN GRAVITY SEWER
 CIVIL
 PLAN AND PROFILE - STA. 17+00 TO STA. 24+00

NO.	ISSUE	DATE	BY	FILE NAME
3	90% DRAFT - FOR REVIEW	7/15/2022	WRH	CV-PP-PIPE01.dwg
2	60% DRAFT - FOR REVIEW	5/16/2022	WRH	
1	30% DRAFT - FOR REVIEW	2/25/2022	WRH	
0	VERIFY SCALE			


Bar is one inch on original drawing. If not one inch on this sheet, adjust scale.

SEQ. **C-2**


ACAD Ref: 24.1s (UMS Tech)
 Filename: N:\W\T\Drawings\CV-PP-PIPE01.dwg
 Last Saved: 6/15/2022 9:25 AM. Saved By: 04327

NOTES:


1. USE TRENCH SAFETY PROTECTION TO MINIMIZE TRENCH WIDTH ALONG RIGHT OF WAY.
2. SINGLE LANE CLOSURE ALONG MARTIN ROAD. PAVEMENT REPAIRS TO CENTERLINE.

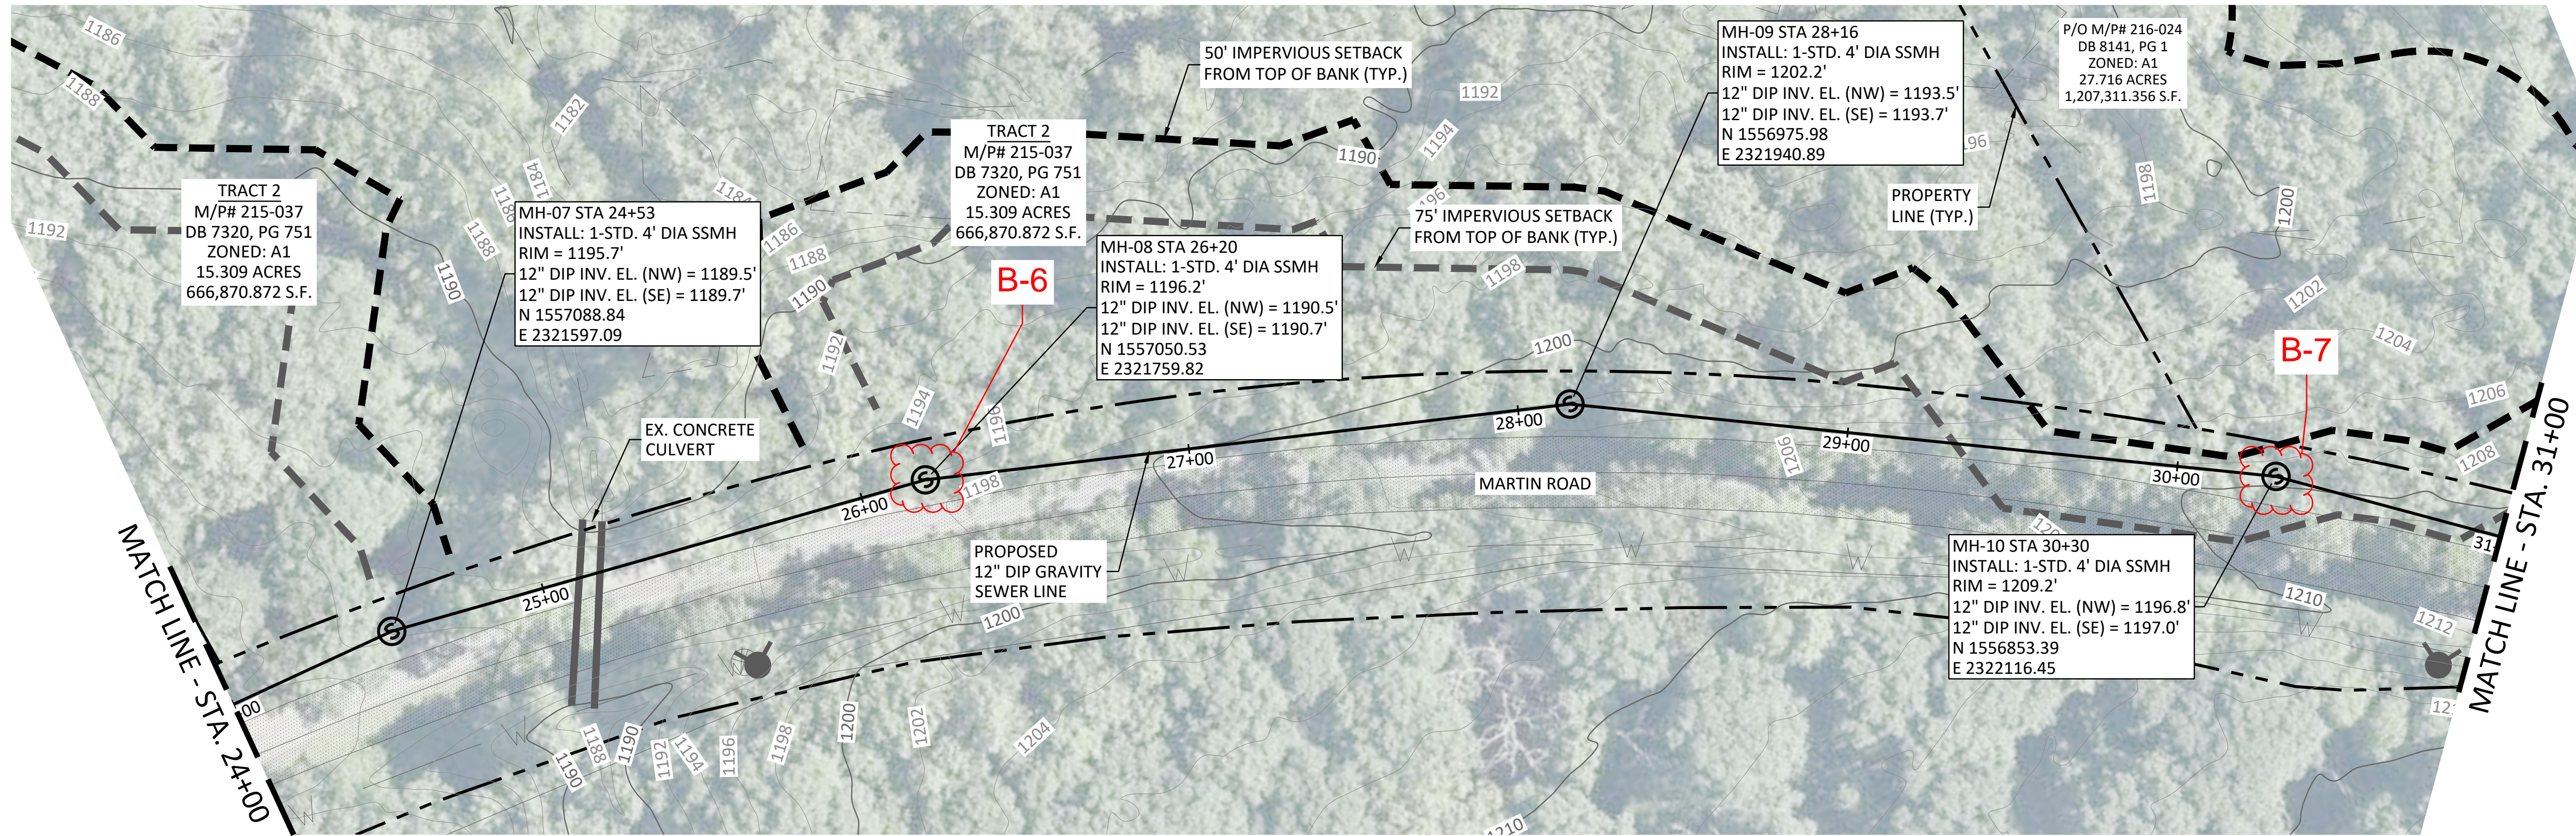

PLAN

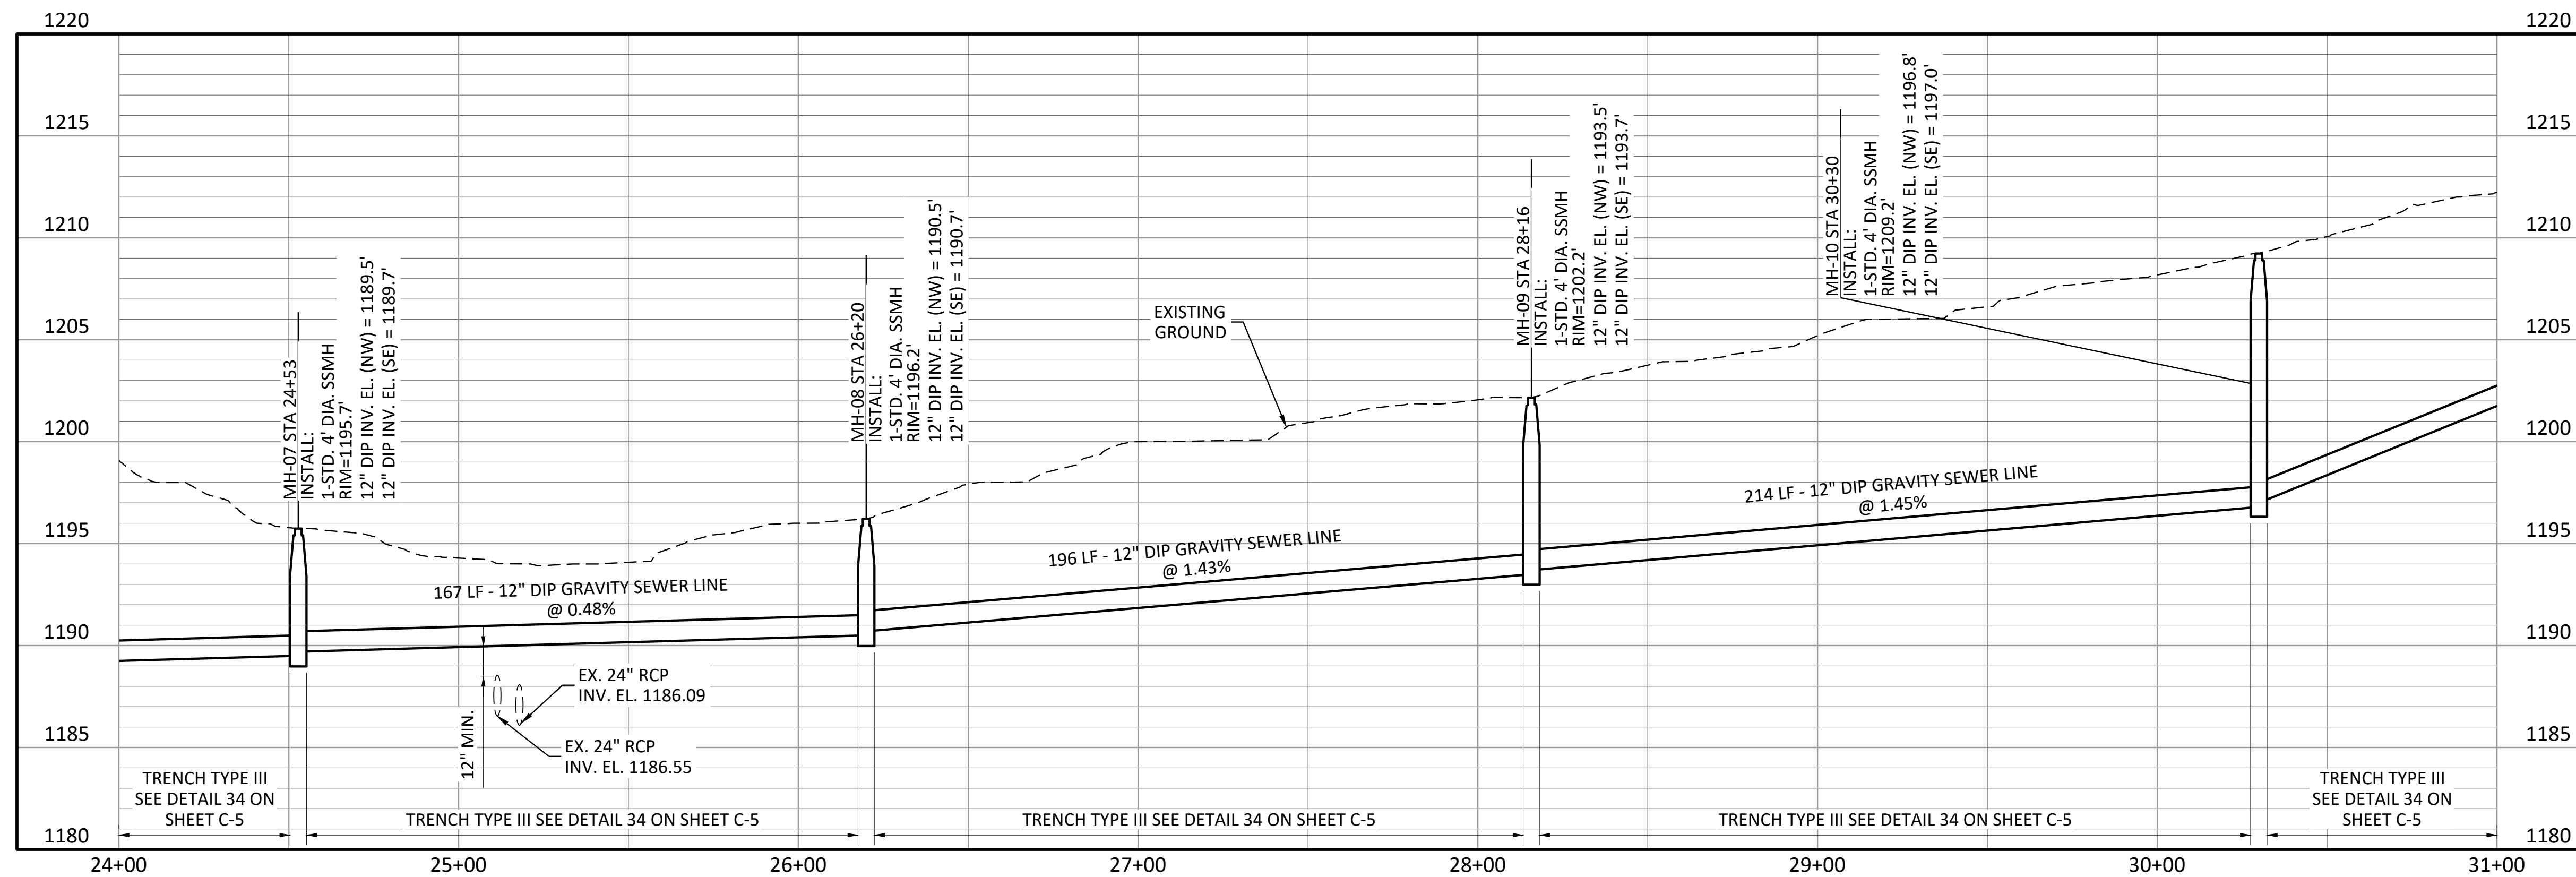

PROFILE

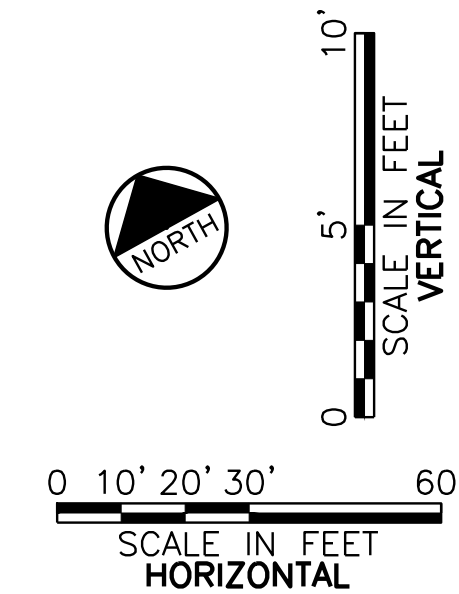

90% SUBMITTAL

NOT FOR CONSTRUCTION
 THIS DOCUMENT IS RELEASED FOR THE PROJECT ONLY. IT IS NOT TO BE USED FOR BIDDING OR PERMIT PURPOSES.
 AUTHORITY OF: WILLIAM ROYCE HACKETT
 GEORGIA NO. PE000572 ON DATE: JUNE 2022

FREES & NICHOLS
 360 Interstate North Parkway
 Atlanta, GA 30339
 Phone: (404) 334-4310
 Web: www.frees.com

FORSYTH COUNTY DEPARTMENT OF WATER AND SEWER
CHURCH AND MARTIN GRAVITY SEWER

CIVIL
PLAN AND PROFILE - STA. 24+00 TO STA. 31+00



NO.	ISSUE	DATE	BY	FILE NAME	CHECKED	WRH
3	90% DRAFT - FOR REVIEW	7/15/2022	WRH	CV-PP-PIPE01.dwg	AFS	SUJ
2	60% DRAFT - FOR REVIEW	5/16/2022	WRH		REVISED	JAR
1	30% DRAFT - FOR REVIEW	2/25/2022	WRH		CHECKED	WRH
0	VERIFY SCALE					

Bar is one inch on original drawing. If not one inch on this sheet, adjust scale.

NO. 3
 SHEET C-3
 SEQ.

ACAD Ref: 24.1s (IMS Tech)
 Filename: N:\W\T\Drawings\CV-PP-PIPE01.dwg
 Last Saved: 6/15/2022 9:25 AM. Saved By: 04327

ACAD Ref: 24.1s (LMS Tech)
 Filename: N:\W\TU\Drawings\CV-PP-PIPE01.dwg
 Last Saved: 6/15/2022 9:25 AM. Saved By: 04327

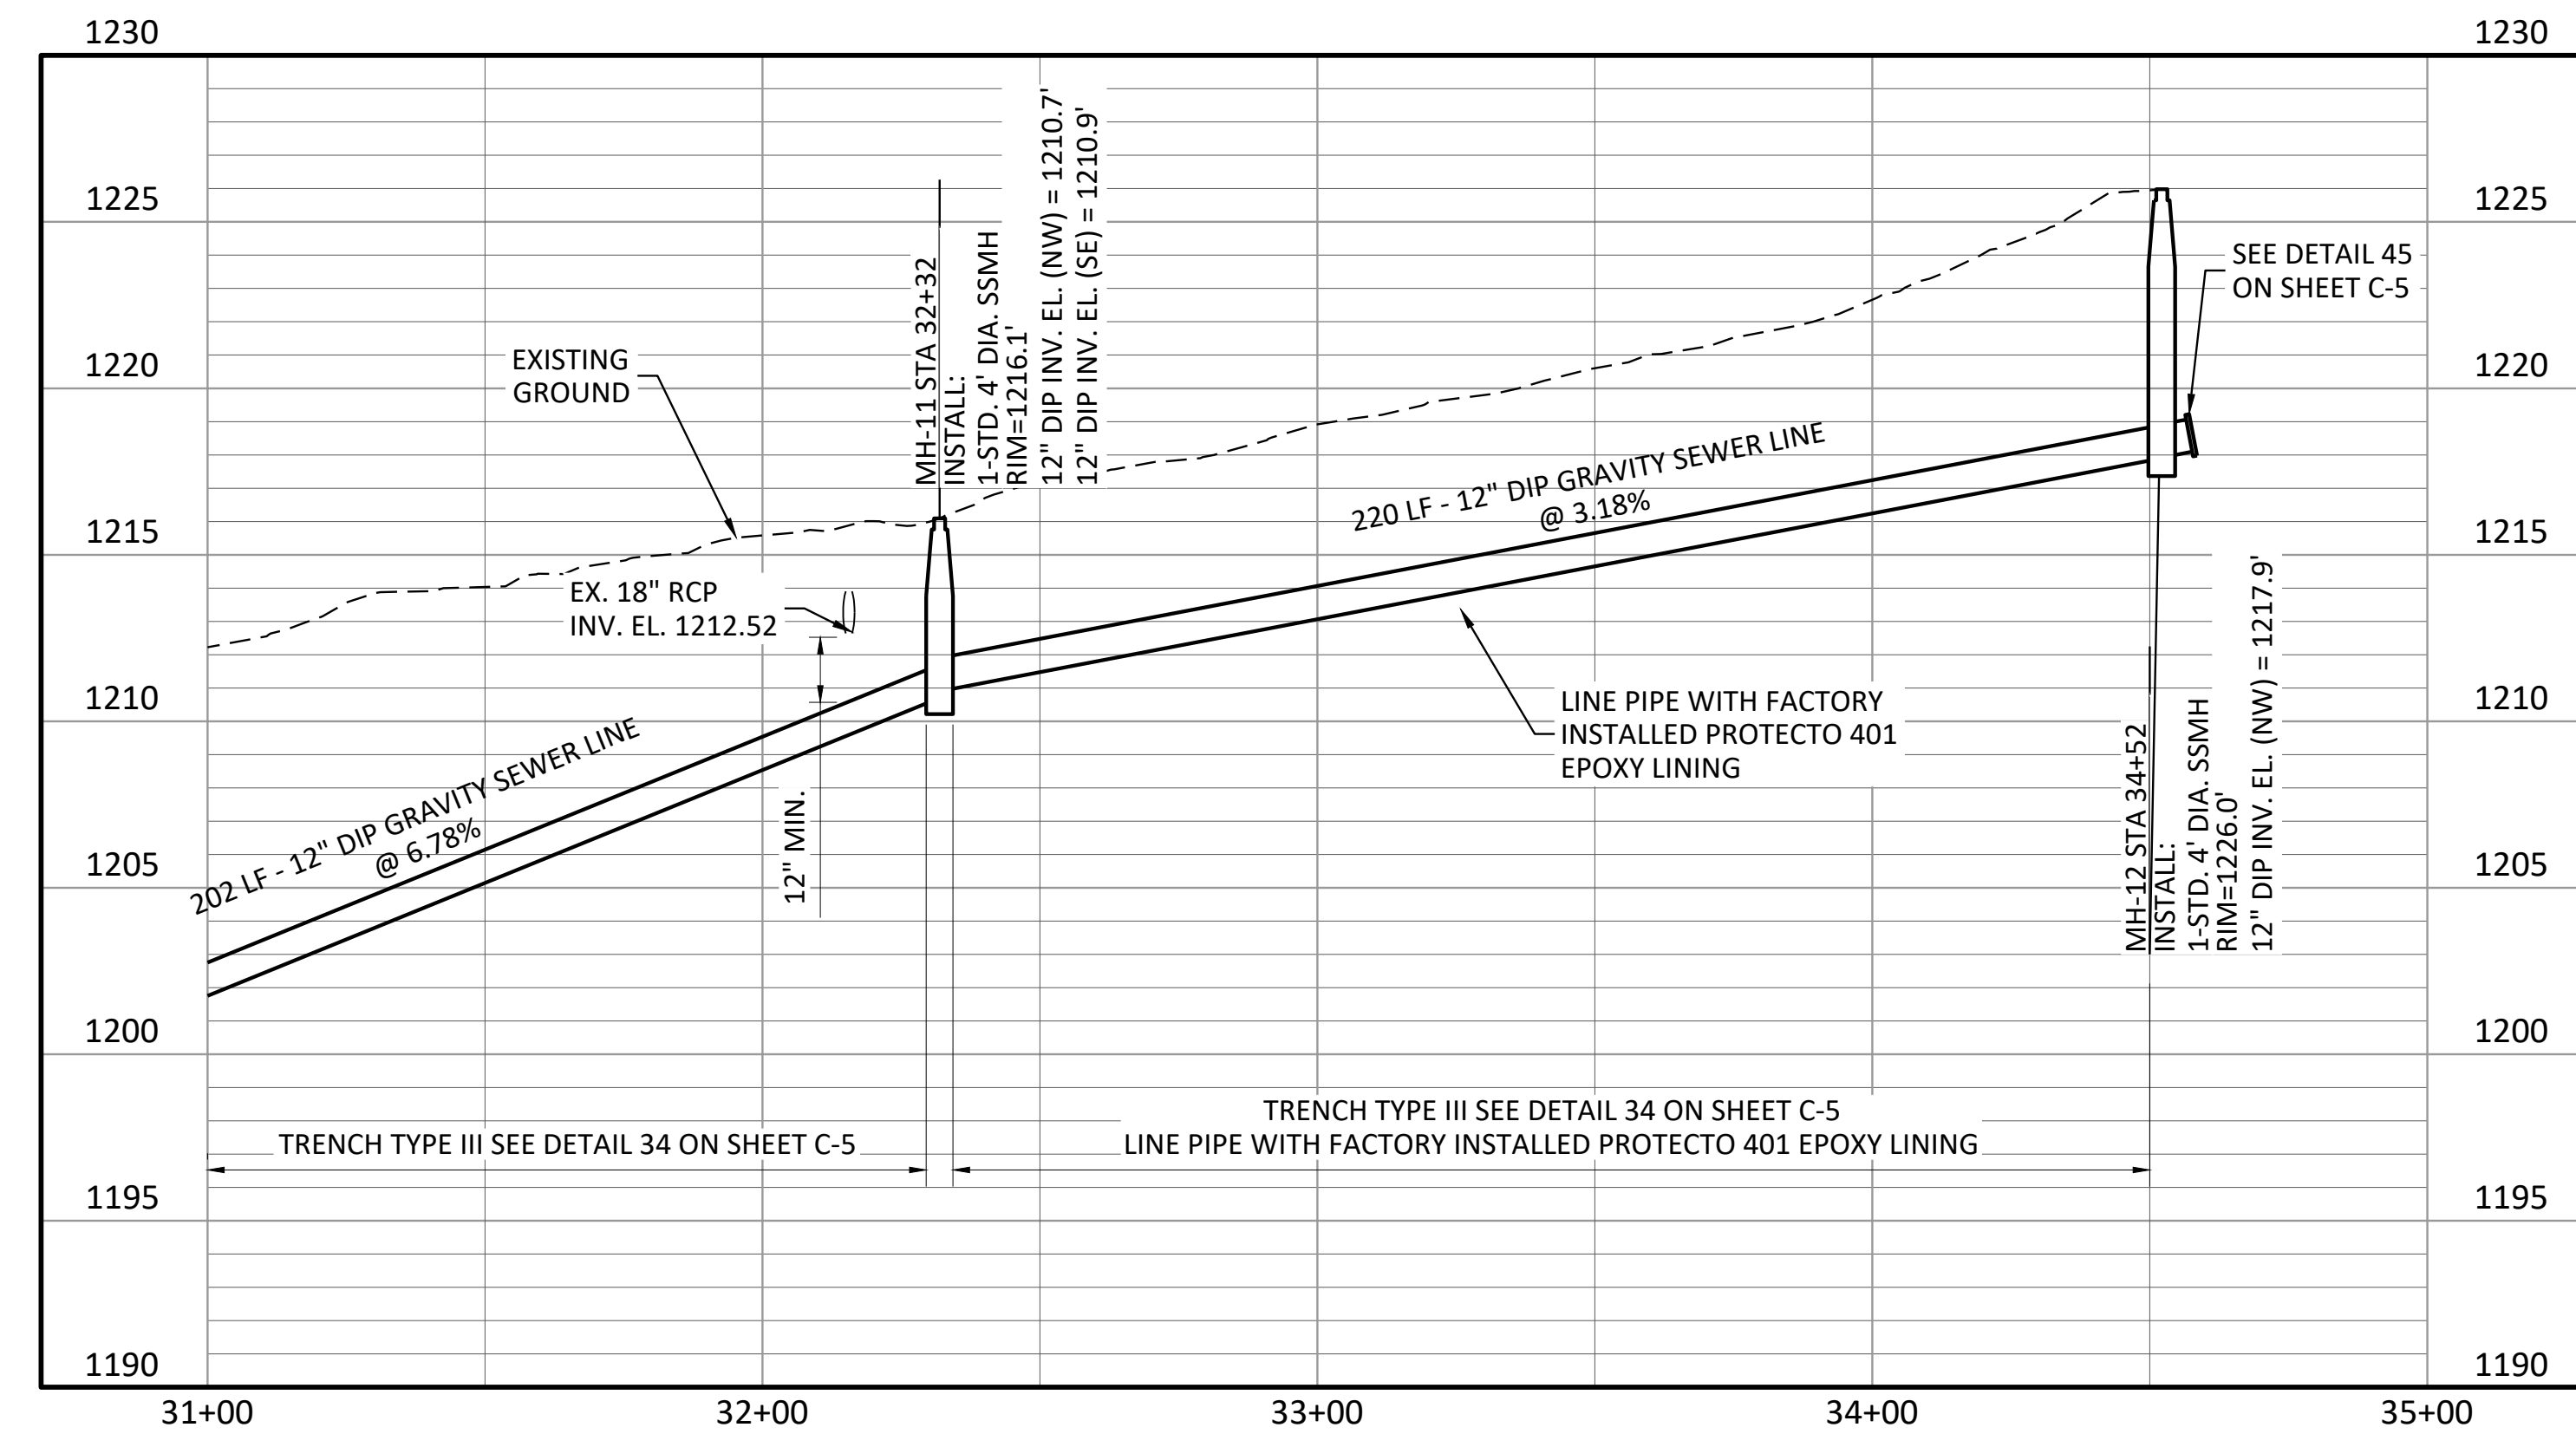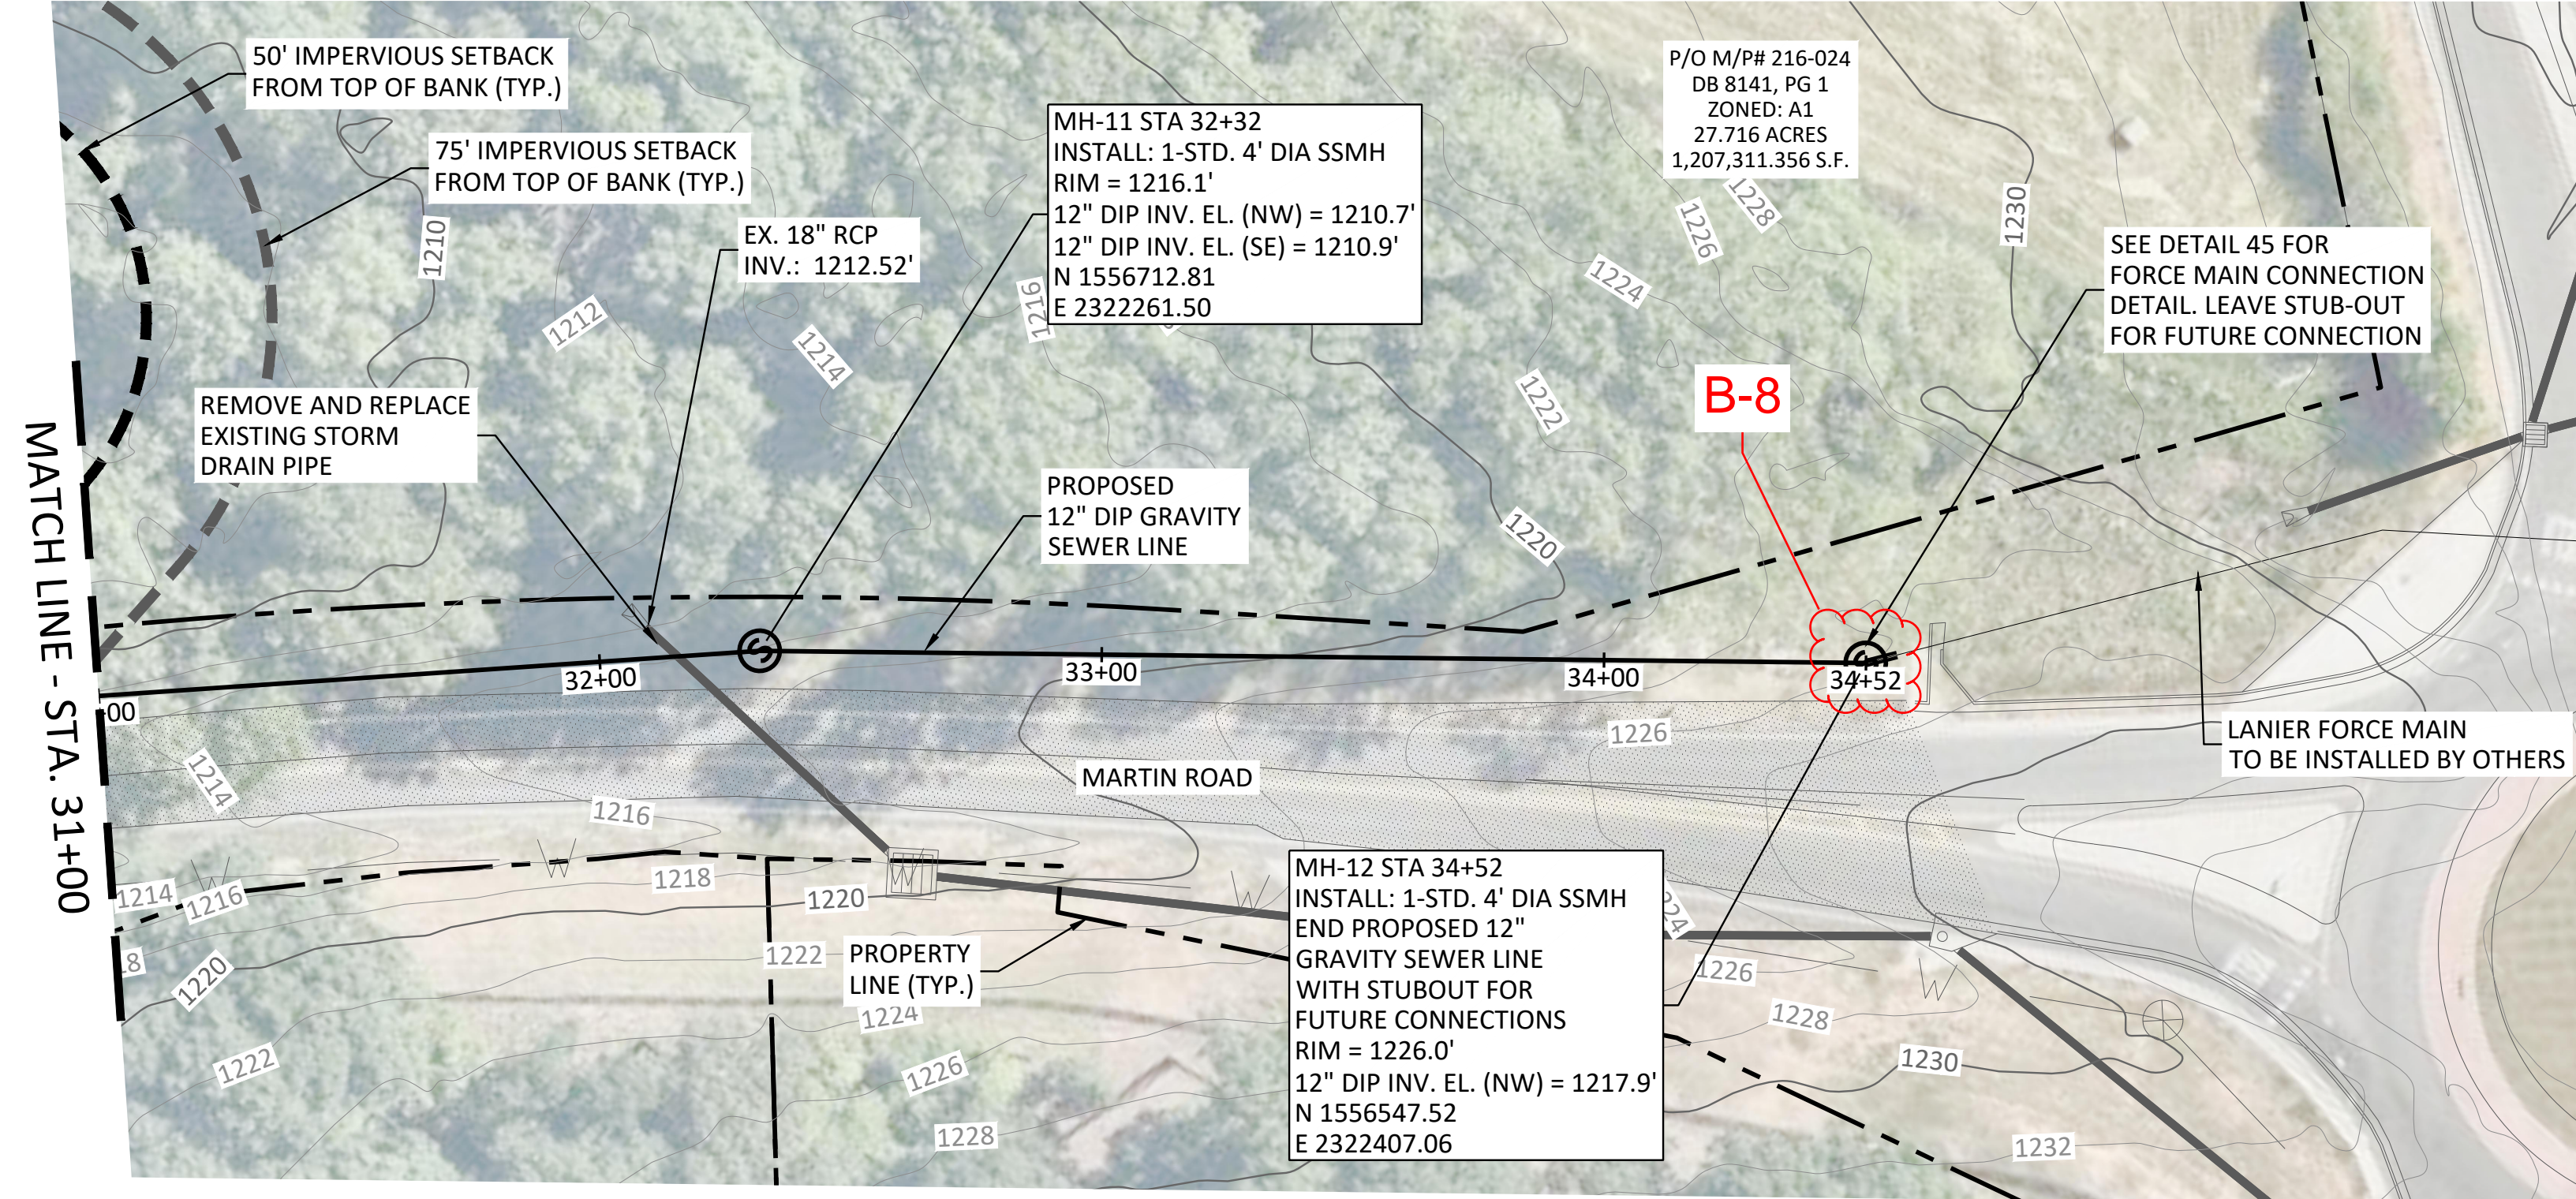

NOTES:

1. USE TRENCH SAFETY PROTECTION TO MINIMIZE TRENCH WIDTH ALONG RIGHT OF WAY.
2. SINGLE LANE CLOSURE ALONG MARTIN ROAD. PAVEMENT REPAIRS TO CENTERLINE.

Freese and Nichols, Inc.
 Georgia Registered Engineering Firm PEF-004433
 Since 1929


NOT FOR CONSTRUCTION
 THIS DOCUMENT IS RELEASED FOR THE PROJECT ONLY. IT IS NOT TO BE USED FOR BIDDING OR PERMIT PURPOSES.
 AUTHORITY OF: WILLIAM ROYCE HACKETT
 GEORGIA NO: PE000572 ON DATE: JUNE 2022

FREES & NICHOLS
 360 Interstate North Parkway,
 Atlanta, GA 30339
 Phone - (404) 334-4310
 Web - www.freese.com

FORSYTH COUNTY DEPARTMENT OF WATER AND SEWER
CHURCH AND MARTIN GRAVITY SEWER

CIVIL
PLAN AND PROFILE - STA. 31+00 TO END STA.

NO.	ISSUE	DATE	BY	DATE	FILE NAME
3	90% DRAFT - FOR REVIEW	JUNE 2022	WRH	7/15/2022	CV-PP-PIPE01.dwg
2	60% DRAFT - FOR REVIEW	AUG 2022	WRH	5/16/2022	
1	30% DRAFT - FOR REVIEW	JUN 2022	WRH	2/25/2022	
0	VERIFY SCALE		WRH		

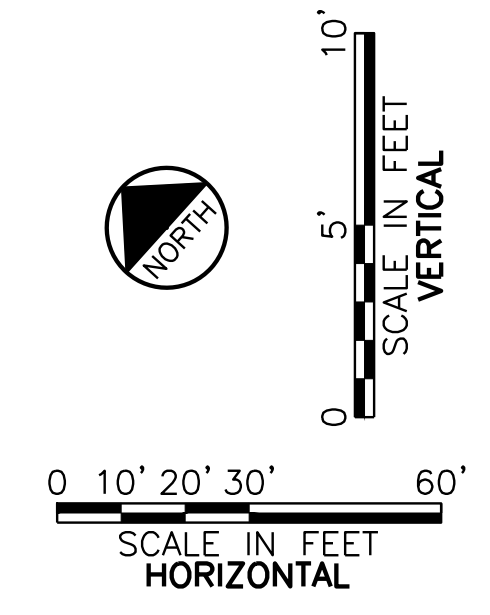

90% SUBMITTAL

SHEET **C-4**
 SEQ.